
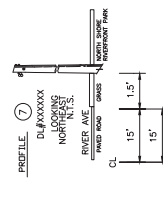
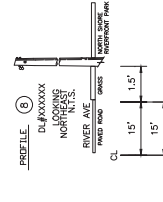
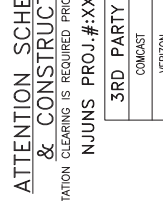
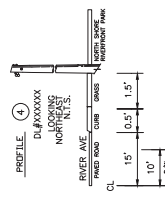
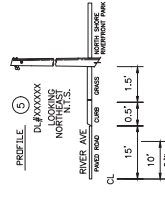
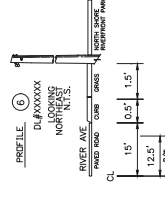
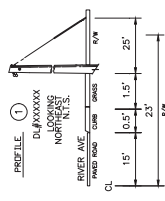
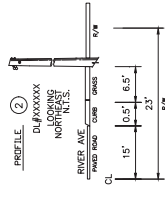
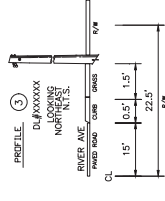


- 1 - 30' (1) (OH=14-28) - 1-AE CL (OH=14-28) ATTACH HT = 23.5
- 2 - 45' (2) (OH=14-28) - 1-AE CL (OH=14-28) ATTACH HT = 37.5
- 3 - 30' (1) (OH=14-28) - 1-AE CL (OH=14-28) ATTACH HT = 23.5
- 4 - 45' (2) (OH=14-28) - 1-AE CL (OH=14-28) ATTACH HT = 37.5
- 5 - 45' (2) (OH=14-28) - 1-AE CL (OH=14-28) ATTACH HT = 37.5
- 6 - 45' (2) (OH=14-28) - 1-AE CL (OH=14-28) ATTACH HT = 37.5
- 7 - 45' (2) (OH=14-28) - 1-AE CL (OH=14-28) ATTACH HT = 37.5
- 8 - 45' (2) (OH=14-28) - 1-AE CL (OH=14-28) ATTACH HT = 37.5

- 1 - 30' (1) (OH=14-28) - 1-AE CL (OH=14-28) ATTACH HT = 23.5
- 2 - 45' (2) (OH=14-28) - 1-AE CL (OH=14-28) ATTACH HT = 37.5
- 3 - 30' (1) (OH=14-28) - 1-AE CL (OH=14-28) ATTACH HT = 23.5
- 4 - 45' (2) (OH=14-28) - 1-AE CL (OH=14-28) ATTACH HT = 37.5
- 5 - 45' (2) (OH=14-28) - 1-AE CL (OH=14-28) ATTACH HT = 37.5
- 6 - 45' (2) (OH=14-28) - 1-AE CL (OH=14-28) ATTACH HT = 37.5
- 7 - 45' (2) (OH=14-28) - 1-AE CL (OH=14-28) ATTACH HT = 37.5
- 8 - 45' (2) (OH=14-28) - 1-AE CL (OH=14-28) ATTACH HT = 37.5


- 1 - 30' (1) (OH=14-28) - 1-AE CL (OH=14-28) ATTACH HT = 23.5
- 2 - 45' (2) (OH=14-28) - 1-AE CL (OH=14-28) ATTACH HT = 37.5
- 3 - 30' (1) (OH=14-28) - 1-AE CL (OH=14-28) ATTACH HT = 23.5
- 4 - 45' (2) (OH=14-28) - 1-AE CL (OH=14-28) ATTACH HT = 37.5
- 5 - 45' (2) (OH=14-28) - 1-AE CL (OH=14-28) ATTACH HT = 37.5
- 6 - 45' (2) (OH=14-28) - 1-AE CL (OH=14-28) ATTACH HT = 37.5
- 7 - 45' (2) (OH=14-28) - 1-AE CL (OH=14-28) ATTACH HT = 37.5
- 8 - 45' (2) (OH=14-28) - 1-AE CL (OH=14-28) ATTACH HT = 37.5

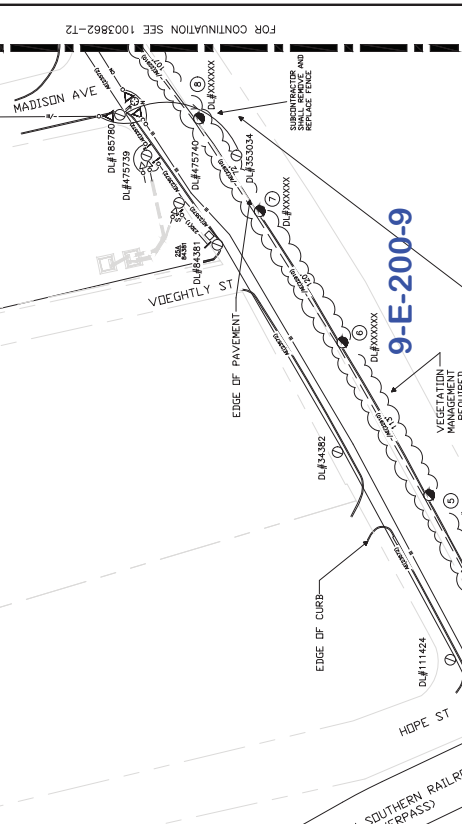


ATTENTION SCHEDULING & CONSTRUCTION:
VEGETATION CLEARING IS REQUIRED PRIOR TO CONSTRUCTION.
NJUNS PROJ.#:XXXXXX



3RD PARTY	
COMCAST	
VERIZON	
SUNESTS	
CROWN CASTLE	
DOE	
AT&T	

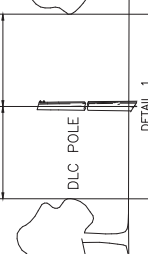

SUMMARY	
DLC WORK	MUNICIPAL
REPLACE POLE	0
INSTALL POLE	8 (1)(2)(3)(4)(5)(6)(7)(8)
INSTALL ANCHOR	2 (1)
REPLACE ANCHOR	0

 

DESIGN PA ONECALL
SERIAL NUMBER
20241101842



RELATED DRAWINGS
1003862 - 10 ~ AS1 TBM DISTRIBUTION ELECTRICAL PLAN COVER SHEET
1003862 - 12 ~ AS1 TBM CONSTRUCTION DRAWING 2
1003862 - 13 ~ AS1 TBM SUMMARY DRAWING

DLC **DESIGN LIGHTING CONSULTANTS**
1003862-11
RIVER AVE
ALCOGAN LOAD GROWTH - OH DISTRIBUTION - AS1 TBM
CITY OF PITTSBURGH/WARD 23
CONSTRUCTION DRAWING 1
DATE: 07/30/2024
DRAWN BY: AMG
CHECKED BY: KAM
SCALE: 1" = 40'

BURNS MEDONNELL
200 W. ADAMS STREET, SUITE 2700
PITTSBURGH, PA 15222

PRELIMINARY - NOT FOR CONSTRUCTION

REVISIONS

NO.	DATE	BY	DESCRIPTION
1			